



DECK PLAN

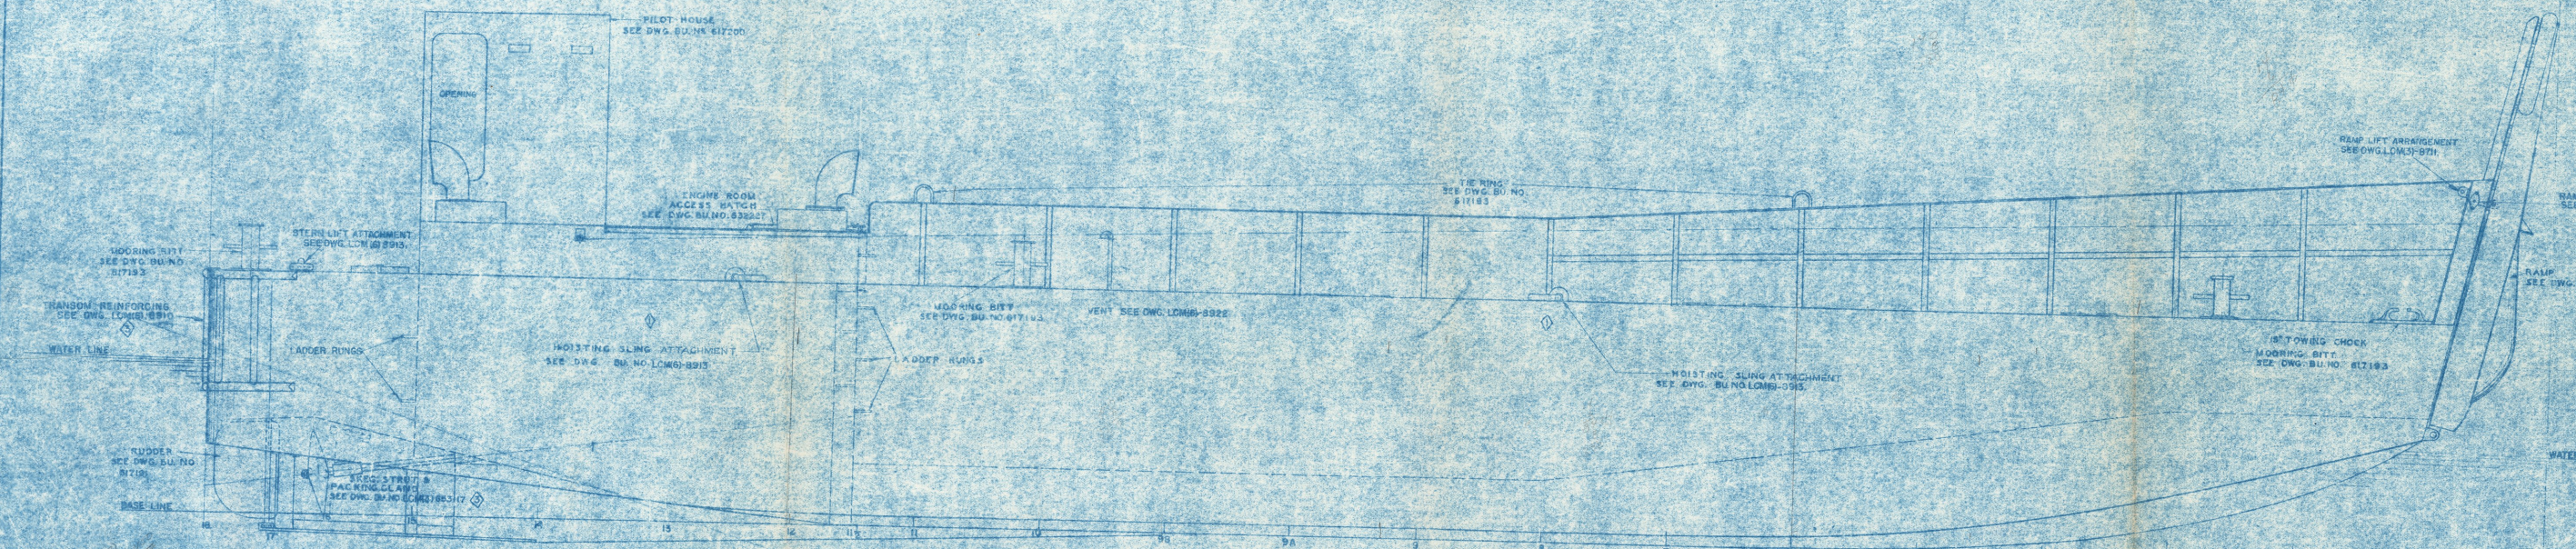

OUTBOARD PROFILE
SCALE 3/4\"/>

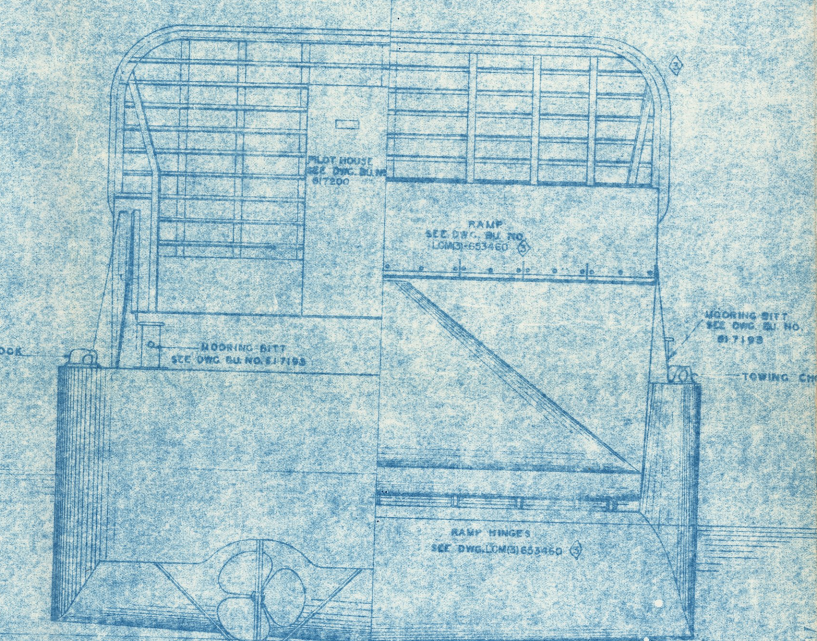

STERN VIEW

BOW VIEW

ALTERATIONS		
NO.	DATE	DESCRIPTION
1	1/23/46	REWORKED PLAN TO PREPARE FOR PRODUCTION DRAWING
2	2/1/46	RAMP DECK PLATES MOVED OUTBOARD
3	2/1/46	SEE PLANS CORRECTED & ADDED, RAMP MODIFIED, TRANSOM REINFORCEMENT ADDED, GEN. NOTE 2 ADDED

GENERAL NOTES

1- FOR PLANS GOVERNING SECTIONALIZING AND PACKING OF SECTIONALIZED PARTS SEE BUREAU OF SHIPS PLANS LCM(6) 8914 TO LCM(6) 8920. IN ADDITION, THE FOLLOWING PLANS ARE APPLICABLE ONLY TO SECTIONALIZED LCM(6):

FUEL PIPING ARRANGEMENT & DETAILS LCM(6) 8901
 FRESH WATER TANKS, DETAILS & PIPING LCM(6) 8902

REFERENCE PLANS:	BU. NO.
POWER OPERATED RAMP HOIST, DIMENSIONS, ASS'Y & DET. LCM(6) 8908	LCM(6) 8908
POWER OPERATED RAMP HOIST-ASSEMBLY LCM(6) 8909	LCM(6) 8909
POWER OPERATED RAMP HOIST-DETAILS (SHEET 1) LCM(6) 8910	LCM(6) 8910
POWER OPERATED RAMP HOIST-DETAILS (SHEET 2) LCM(6) 8911	LCM(6) 8911
POWER OPERATED RAMP HOIST-INSTALLATION LCM(6) 8912	LCM(6) 8912
RAMP LIFT-ARRANGEMENTS LCM(6) 8913	LCM(6) 8913
RAMP SAFETY LATCH FOOT TREADLE ASSEMBLY LCM(6) 8914	LCM(6) 8914
RAMP SAFETY LATCH FOOT TREADLE DETAILS LCM(6) 8915	LCM(6) 8915
SET TIE BARS, DETAILS & FOUNDATIONS LCM(6) 8916	LCM(6) 8916
STRUCTURAL PLAN LCM(6) 8917	LCM(6) 8917
SIDE AND BOTTOM CONSTRUCTION LCM(6) 8918	LCM(6) 8918
CONSTRUCTION SECTIONS, SHEET NO. 1 LCM(6) 8919	LCM(6) 8919
CONSTRUCTION SECTIONS, SHEET NO. 2 LCM(6) 8920	LCM(6) 8920
CONSTRUCTION SECTIONS, SHEET NO. 3 LCM(6) 8921	LCM(6) 8921
MOORING SKINGS LCM(6) 8922	LCM(6) 8922
FREE-STRUTTING CLANG, ASSEMBLY & DETAILS LCM(6) 8923	LCM(6) 8923
RAMP ARRANGEMENT AND DETAILS LCM(6) 8924	LCM(6) 8924
SET COMPONENTS-CHECK PLATES, ACCESS, ARREST, VENTING LCM(6) 8925	LCM(6) 8925
MISCELLANEOUS DETAILS LCM(6) 8926	LCM(6) 8926
LINE AND OFFSETS LCM(6) 8927	LCM(6) 8927
STEERING GEAR ASSEMBLY AND DETAILS LCM(6) 8928	LCM(6) 8928
HALE RECTANGULAR LIST LCM(6) 8929	LCM(6) 8929
FORWARD FUEL TANKS, DETAILS & FOUNDATIONS LCM(6) 8930	LCM(6) 8930
ENGINE REF. DETAILS LCM(6) 8931	LCM(6) 8931
VENTILATING SYSTEM LCM(6) 8932	LCM(6) 8932
DETAILS OF PILOT HOUSE AND STEERING STAND LCM(6) 8933	LCM(6) 8933
DETAILS OF PILOT HOUSE, STEERING STAND & ENGINE BEARINGS LCM(6) 8934	LCM(6) 8934
ENGINE HATCH DETAILS LCM(6) 8935	LCM(6) 8935
PROPELLER LCM(6) 8936	LCM(6) 8936
SALT WATER AND EXHAUST SYSTEM LCM(6) 8937	LCM(6) 8937
FUEL SYSTEM LCM(6) 8938	LCM(6) 8938
WHEEL SYSTEM LCM(6) 8939	LCM(6) 8939
WHEEL AND THROTTLE CONTROLS ASSEMBLY LCM(6) 8940	LCM(6) 8940
ELECTRICAL PLAN LCM(6) 8941	LCM(6) 8941

**LANDING CRAFT MECHANIZED
MARK VI WELL TYPE
LCM (6)**

OUTBOARD PROFILE AND DECK PLAN
 SCALE 3/4\"/>

BUREAU OF SHIPS NUMBER
 LCM (6) 8905

APR 1946

100% RAG CONTENT